

Notes:

PARTITION LEGEND	
[Symbol]	EXISTING WALL, VERIFY CONSTRUCTION IN FIELD
[Symbol]	NEW INTERIOR PARTITION



PARTITION NOTES	
1.	ALL WALLS NOT KEYED IN BY WALL TYPE DESIGNATION TO BE PARTITION "P1", TYP

DIMENSIONING NOTES	
1.	EXTERIOR MASONRY WALLS ARE DIMENSIONED TO THE FACE OF MASONRY
2.	INTERIOR MASONRY WALLS ARE DIMENSIONED TO THE FACE OF MASONRY
3.	WOOD FRAMED EXTERIOR WALLS ARE DIMENSIONED TO THE EXTERIOR FACE OF STUD
4.	INTERIOR PARTITIONS ARE DIMENSIONED TO THE CENTERLINE, UCN

FIRE EXTINGUISHER SCHEDULE	
FE-1	RECESSED FIRE EXTINGUISHER - 1-1/2" TRIM, JI INDUSTRIES COSMIC 5X, 3A-40BC CABINET #1826G17, MILL FINISH

INTERIOR ELEVATIONS NOTES	
MILLWORK:	1. SEE MILLWORK NOTES ON SHEET A.001 FOR SPECIES OF TYPICAL WOODS AND WOOD VENEERS

PLUMBING FIXTURE LIST	
S1: KITCHEN SINK	ELKAY DAYTON STAINLESS STEEL SINGLE BOWL TOP MOUNT SINK MODEL: D12521 WITH AMERICAN STANDARD SINGLE CONTROL KITCHEN FAUCET COLONY SOFT MODEL: 4175.500.F15

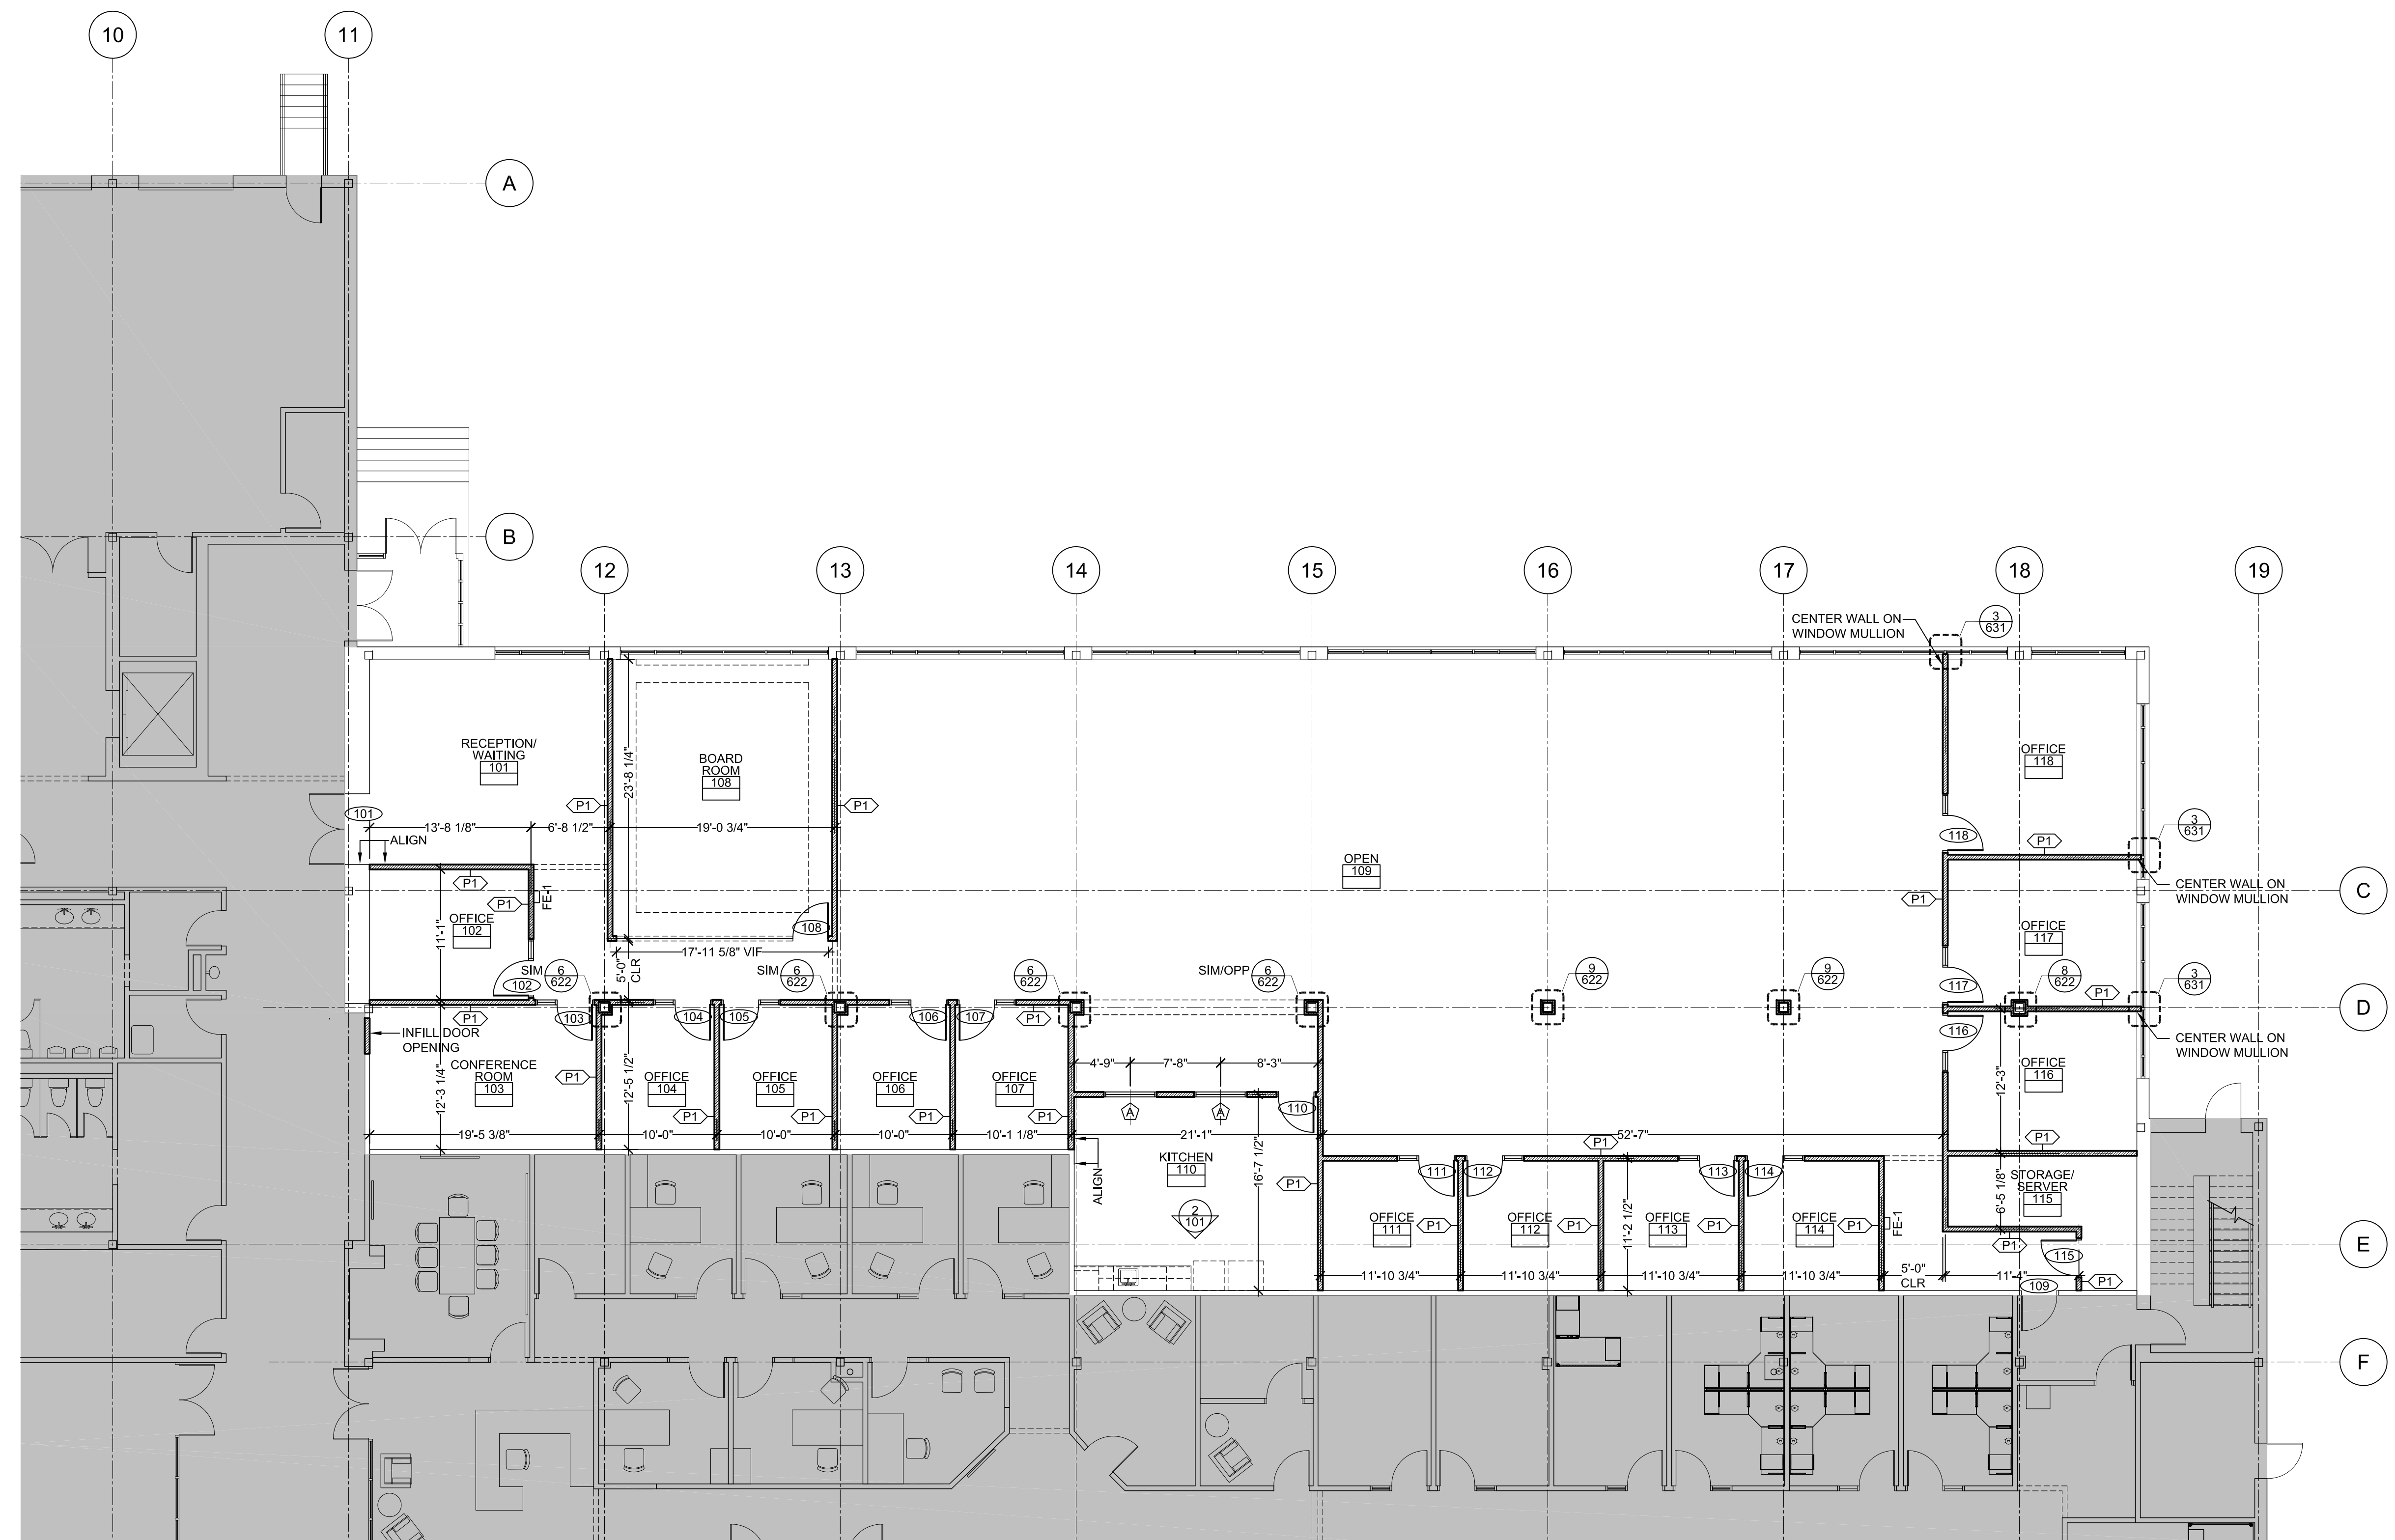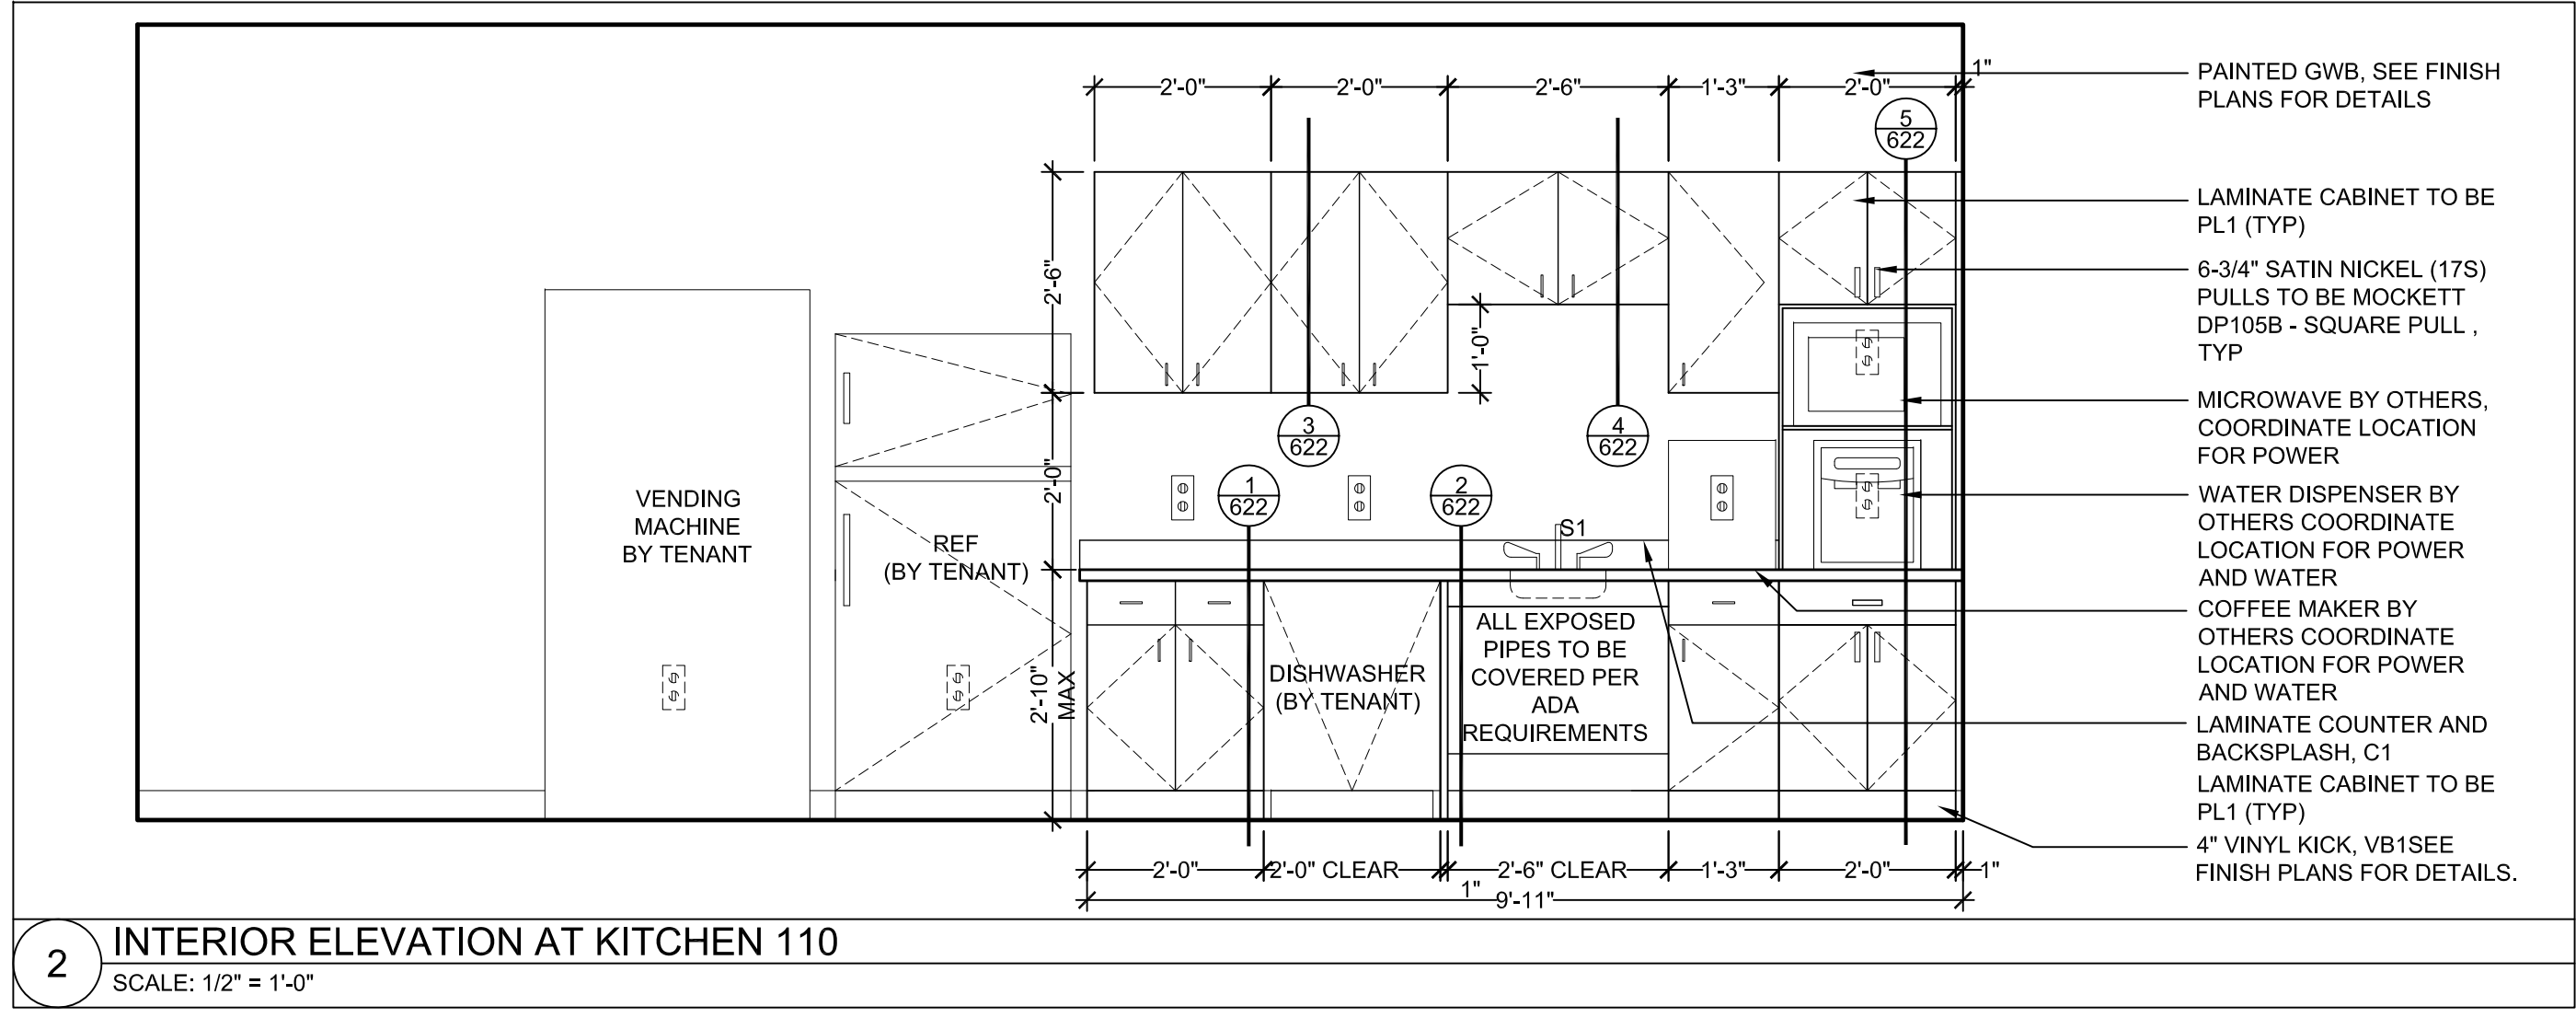

Key Plan:

Architect's Stamp:

Project:

Contract Logix
55 Technology Drive
Lowell, MA 01851
Client: Novaya Real Estate Ventures
120 Water Street, Third Floor
Boston, MA 02109
617-391-3577
Project #: 15113
Scale: As Noted

Issue: Permit Set Date: 12/18/2015

Revisions:	Date:




Drawing Title:
First Floor Plan

Sheet Number:
A.101
MAUGEL ARCHITECTS INC

200 Ayer Road, Harvard, MA 01451
Tel: (978) 456-2800 Fax: (978) 456-2801
www.maugel.com

FIRST FLOOR PLAN 1
SCALE: 1/8" = 1'-0"

THESE DOCUMENTS AND ALL IDEAS, ARRANGEMENTS, DESIGNS AND PLANS INDICATED THEREON OR REPRESENTED THEREON ARE OWNED BY AND REMAIN THE PROPERTY OF MAUGEL ARCHITECTS, INC. AND NO PART THEREOF SHALL BE REPRODUCED OR TRANSMITTED IN ANY FORM OR BY ANY MEANS, ELECTRONIC OR MECHANICAL, INCLUDING PHOTOCOPYING, RECORDING, OR BY ANY INFORMATION STORAGE AND RETRIEVAL SYSTEM, WITHOUT THE WRITTEN PERMISSION OF MAUGEL ARCHITECTS, INC.

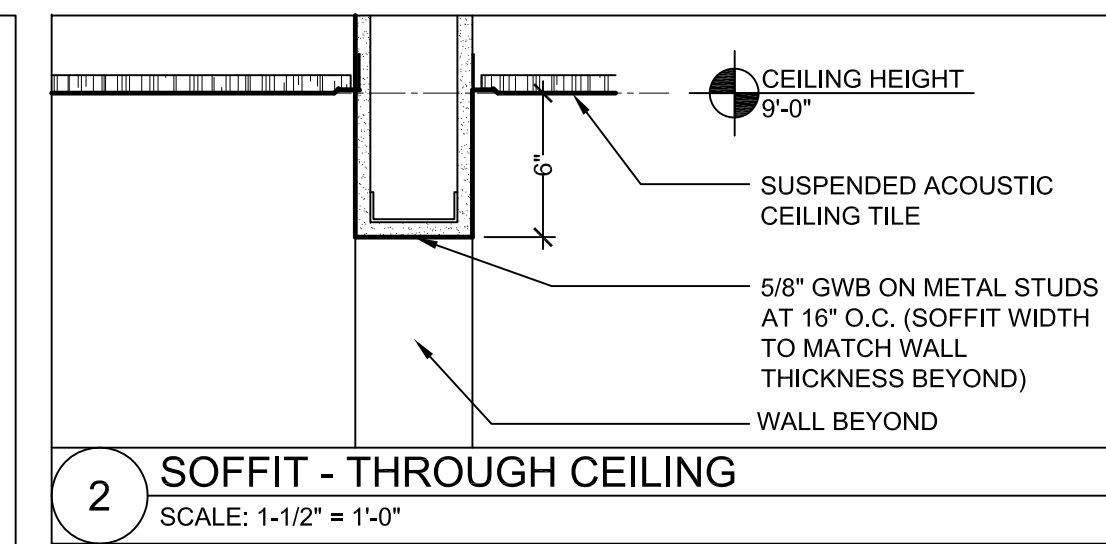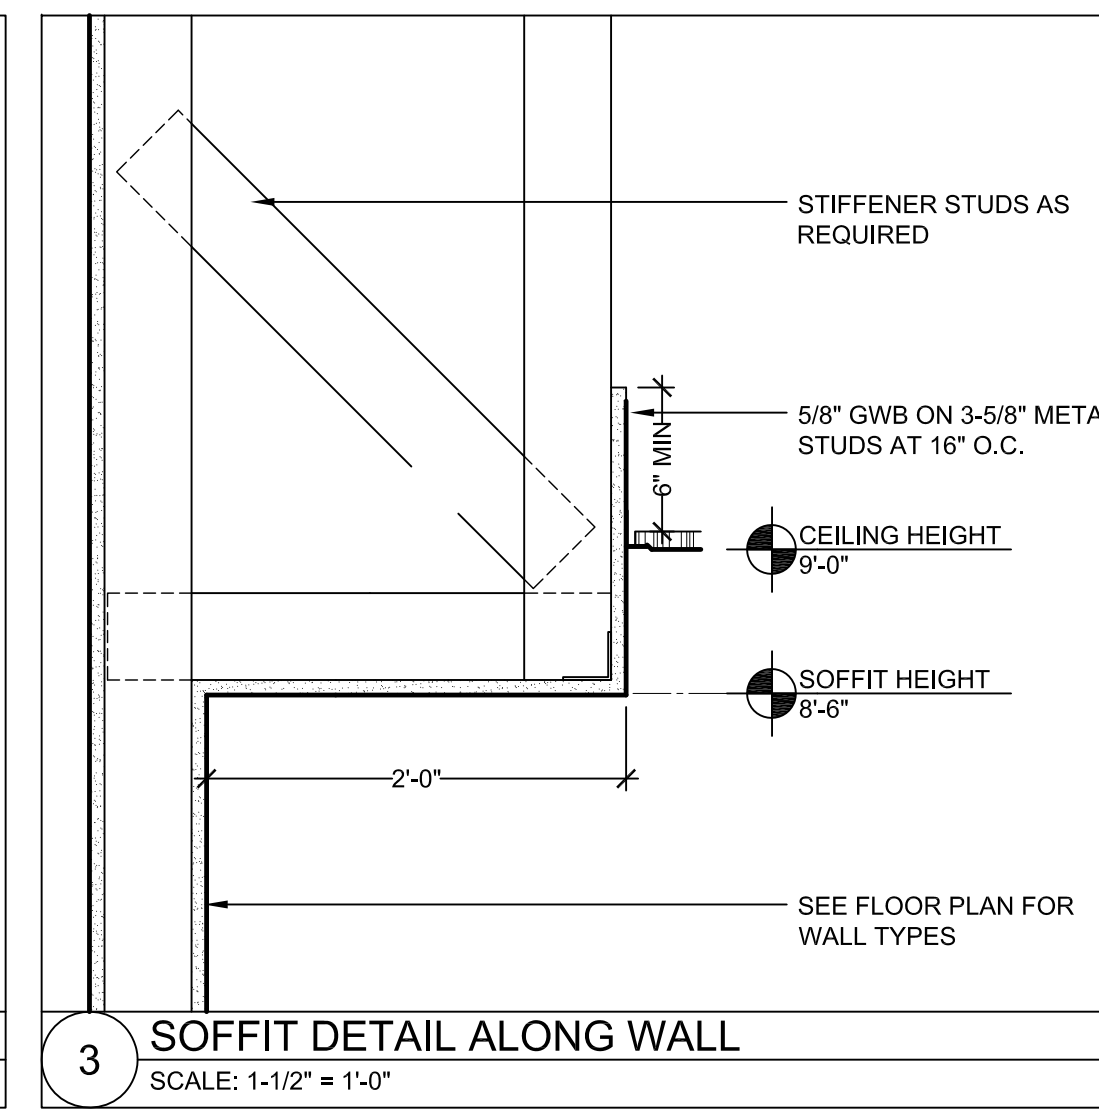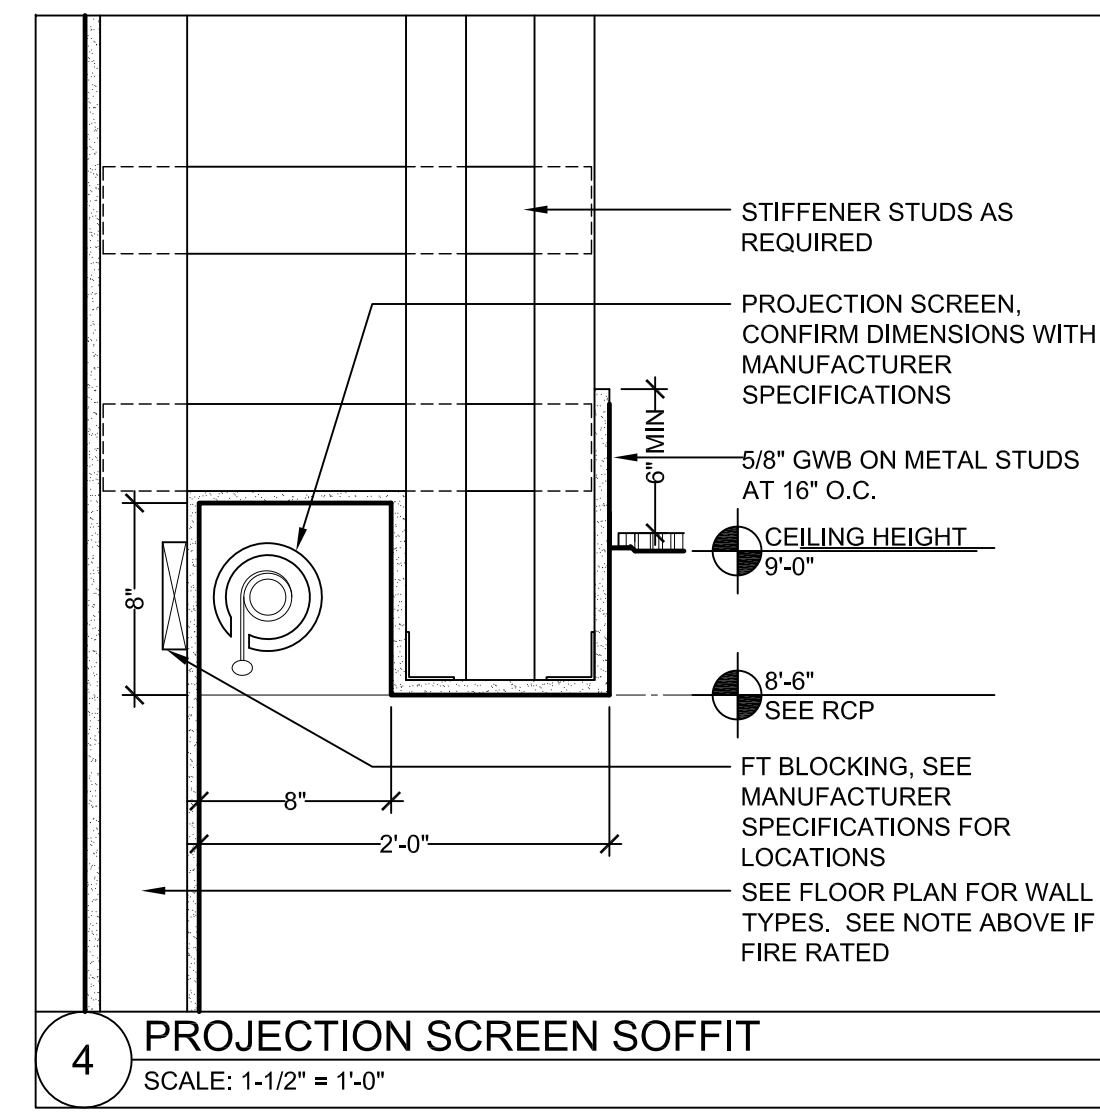

Notes:

RCP LEGEND	
	2'X2' INDIRECT/DIRECT FLUORESCENT LIGHT - MODEL TBD - LAMPS T8
	2'X4' INDIRECT/DIRECT FLUORESCENT LIGHT - MODEL TBD - LAMPS T8

CEILING TYPES	
	2'X4' SECOND LOOK ACOUSTIC CEILING TILE, ARMSTRONG "CORTEGA SECOND LOOK III" #2767, ANGLED TEGULAR, W/ 15/16" PRELUDE GRID, COLOR WHITE

CEILING NOTES

- NOTES ON SHEET A.621 ALSO APPLY TO FRAMING OF CEILING STRUCTURES, TYPICAL.
- ALL CEILING GRIDS ARE TO BE CENTERED IN ROOMS AND/OR SPACES UNLESS NOTED OTHERWISE
- ALL DOWN LIGHTS IN CEILING GRIDS ARE TO BE CENTERED IN GRID, TYPICAL
- ALL DOWN LIGHTS IN CONFERENCE ROOMS, OFFICES, BOARD ROOMS, ETC. ARE TO BE ON SEPARATE DIMMABLE SWITCHES, TYPICAL
- ALL EXIT SIGNS, LIGHTS WITH EMERGENCY BACKUP, AND RELATED LIFE SAFETY EQUIPMENT ARE THE RESPONSIBILITY OF THE ELECTRICAL ENGINEER, G.C. TO COORDINATE ENGINEERED DRAWINGS WITH ARCHITECTURALS

Key Plan:

Architect's Stamp:

Project:

Contract Logix
 55 Technology Drive
 Lowell, MA 01851

Client:
 Novaya Real Estate Ventures
 120 Water Street, Third Floor
 Boston, MA 02109
 617-391-3577

Project #: 15113

Scale: As Noted

Issue: Permit Set **Date:** 12/18/2015

Revisions: **Date:**

Drawing Title:
 First Floor Reflected Ceiling Plan

Sheet Number:
A.701

MAUGEL ARCHITECTS INC.

200 Ayer Road, Harvard, MA 01451
 Tel: (978) 456-2800 Fax: (978) 456-2801
 www.maugel.com


THESE DOCUMENTS AND ALL IDEAS, ARRANGEMENTS, DESIGNS AND PLANS INDICATED THEREON OR REPRESENTED THEREON ARE OWNED BY AND REMAIN THE PROPERTY OF MAUGEL ARCHITECTS, INC. AND NO PART THEREOF SHALL BE REPRODUCED OR TRANSMITTED IN ANY FORM OR BY ANY MEANS, ELECTRONIC OR MECHANICAL, INCLUDING PHOTOCOPYING, RECORDING, OR BY ANY INFORMATION STORAGE AND RETRIEVAL SYSTEM, WITHOUT THE WRITTEN PERMISSION OF MAUGEL ARCHITECTS, INC.

FIRST FLOOR REFLECTED CEILING PLAN 1
 SCALE: 1/8" = 1'-0"

Notes:

ELECTRICAL LEGEND	
	DUPLEX OUTLET - CENTER OF OUTLET AT 18" AFF
	DUPLEX OUTLET (G.F.I.) - CENTER OF OUTLET AT 6" ABOVE BACKSPLASH OR AT 48" AFF
	DEDICATED OUTLET - CENTER OF OUTLET AT 18" AFF
	DEDICATED OUTLET - CENTER OF OUTLET AT 6" ABOVE BACKSPLASH OR AT 48" AFF
	DUPLEX OUTLET (FLOOR MOUNTED)
	DATA JACK - FLOOR MOUNTED
	COMBINATION TELEPHONE / DATA JACK - CENTER OF OUTLET AT 18" AFF
	COMBINATION TELEPHONE / DATA JACK (DOUBLE) - CENTER OF OUTLET AT 18" AFF

ELECTRICAL NOTES	
1.	ELECTRICAL SUBCONTRACTOR IS TO PROVIDE PULL STRINGS AND JUNCTION BOXES FOR ALL DATA LINES, TYPICAL.
2.	ARCHITECTURAL PLANS DEPICT ELECTRICAL OUTLET TYPES AND LOCATIONS ARE FOR COORDINATION PURPOSES ONLY. FINAL OUTLET TYPES AND LOCATIONS TO BE DETERMINED BY ELECTRICAL ENGINEER.

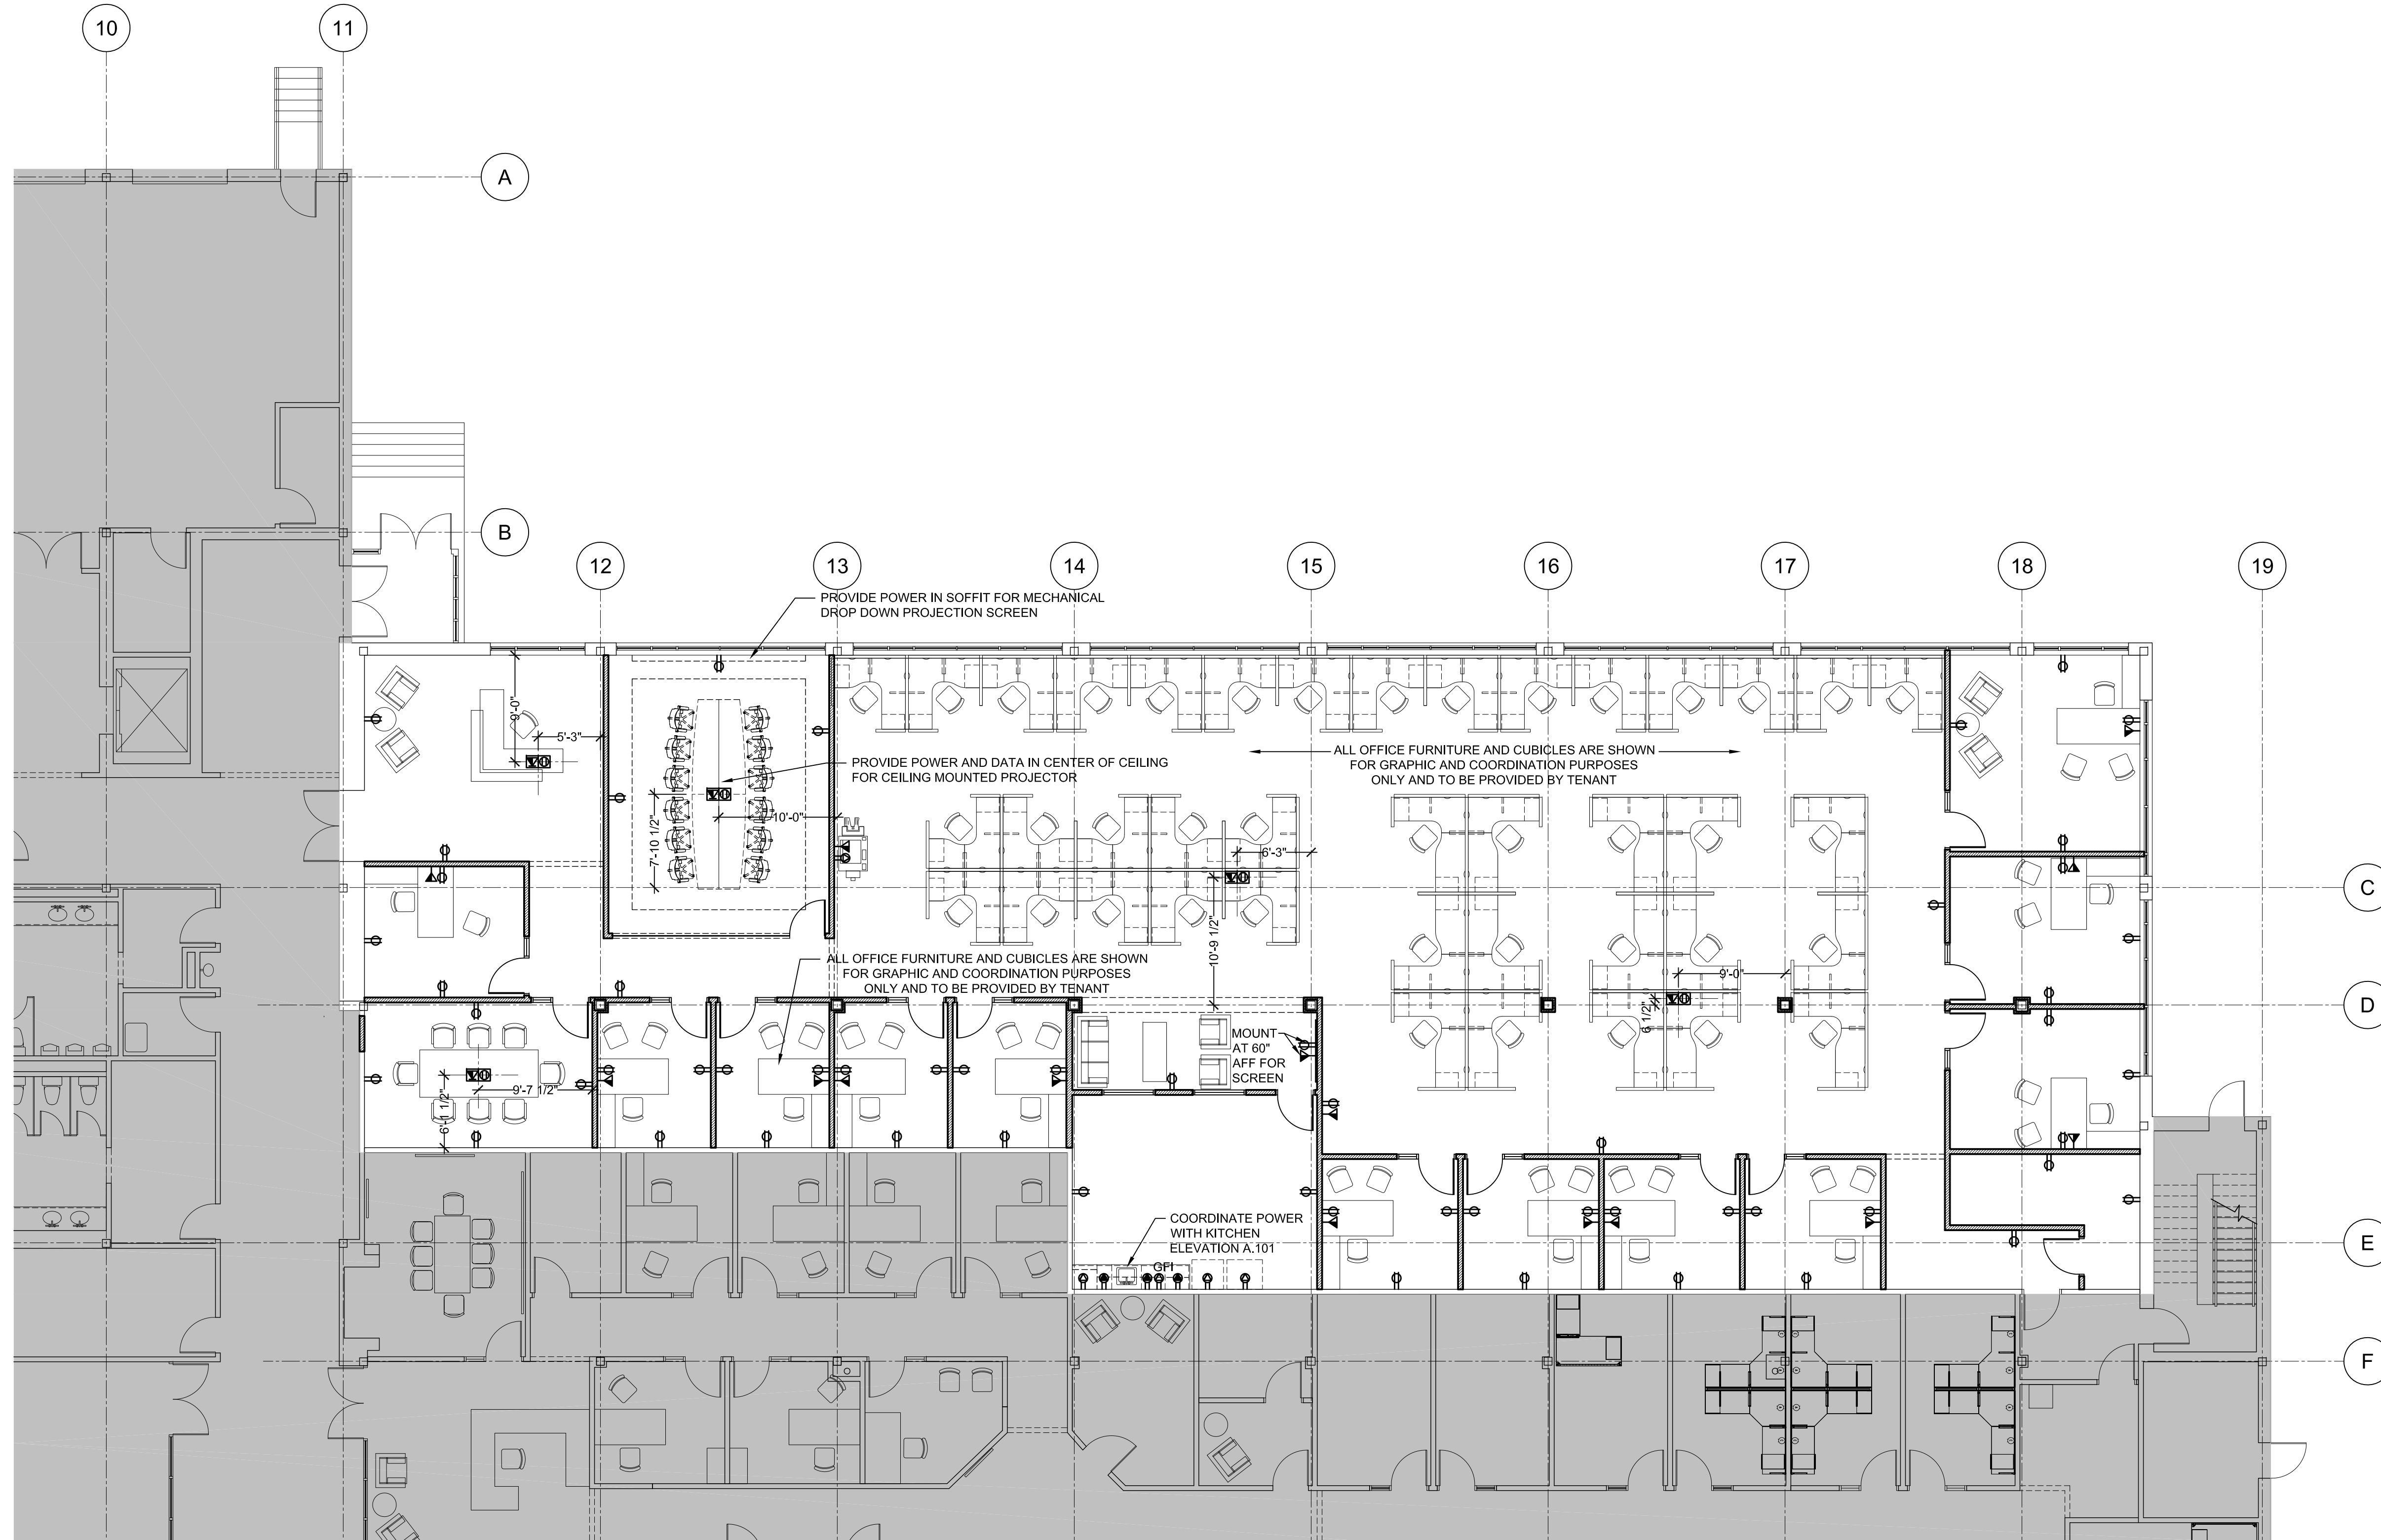

Key Plan:

Architect's Stamp:

Project:

Contract Logix
 55 Technology Drive
 Lowell, MA 01851
 Client:
 Novaya Real Estate Ventures
 120 Water Street, Third Floor
 Boston, MA 02109
 617-391-3577
 Project #: 15113
 Scale: As Noted

Issue: Permit Set
 Date: 12/18/2015

Revisions:	Date:

Drawing Title:
 First Floor Coordination Plan

Sheet Number:

A.901



200 Ayer Road, Harvard, MA 01451
 Tel: (978) 456-2800 Fax: (978) 456-2801
 www.maugel.com

FIRST FLOOR COORDINATION PLAN 1
 SCALE: 1/8" = 1'-0"

THESE DOCUMENTS AND ALL IDEAS, ARRANGEMENTS, DESIGNS AND PLANS INDICATED THEREON OR REPRESENTED THEREON ARE OWNED BY AND REMAIN THE PROPERTY OF MAUGEL ARCHITECTS, INC. AND NO PART THEREOF SHALL BE REPRODUCED OR TRANSMITTED IN ANY FORM OR BY ANY MEANS, ELECTRONIC OR MECHANICAL, INCLUDING PHOTOCOPYING, RECORDING, OR BY ANY INFORMATION STORAGE AND RETRIEVAL SYSTEM, WITHOUT THE WRITTEN PERMISSION OF MAUGEL ARCHITECTS, INC.